



FIRE SYMBOLS

- Smoke Detector
- Heat Detector
- Evacuation Sounder
- Evacuation Projection Sounder
- Fire Alarm Panel
- Carbon Dioxide Extinguisher
- Multipurpose Extinguisher
- Fire Door
- Emergency Light with Emergency Exit with Running Man Sign - Fully Maintained
- Emergency Light - Ceiling general luminaire - Fully Maintained with directional sign
- Emergency Light - Ceiling general luminaire - Fully Maintained
- Emergency Light - Ceiling general luminaire - Not Maintained
- Emergency Exit Light - Ceiling general luminaire - Not Maintained
- Fire Alarm Call Point
- Fire Alarm Call Point
- Mute call off system
- Magnetism sensor linked to F.A.

SECOND FLOOR PLAN
SCALE 1:100@A1

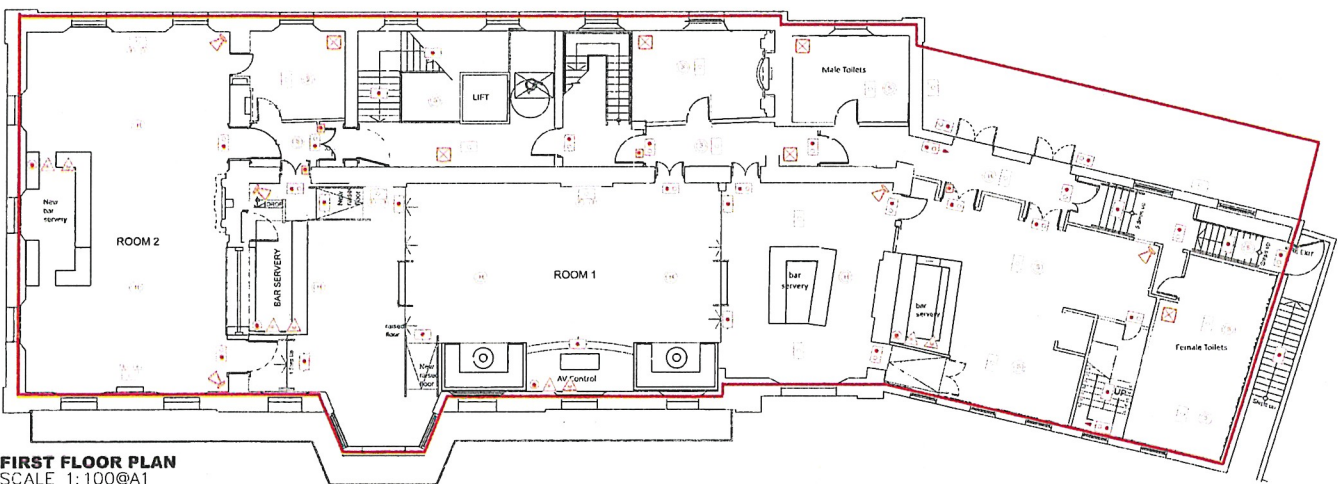

FIRST FLOOR PLAN
SCALE 1:100@A1

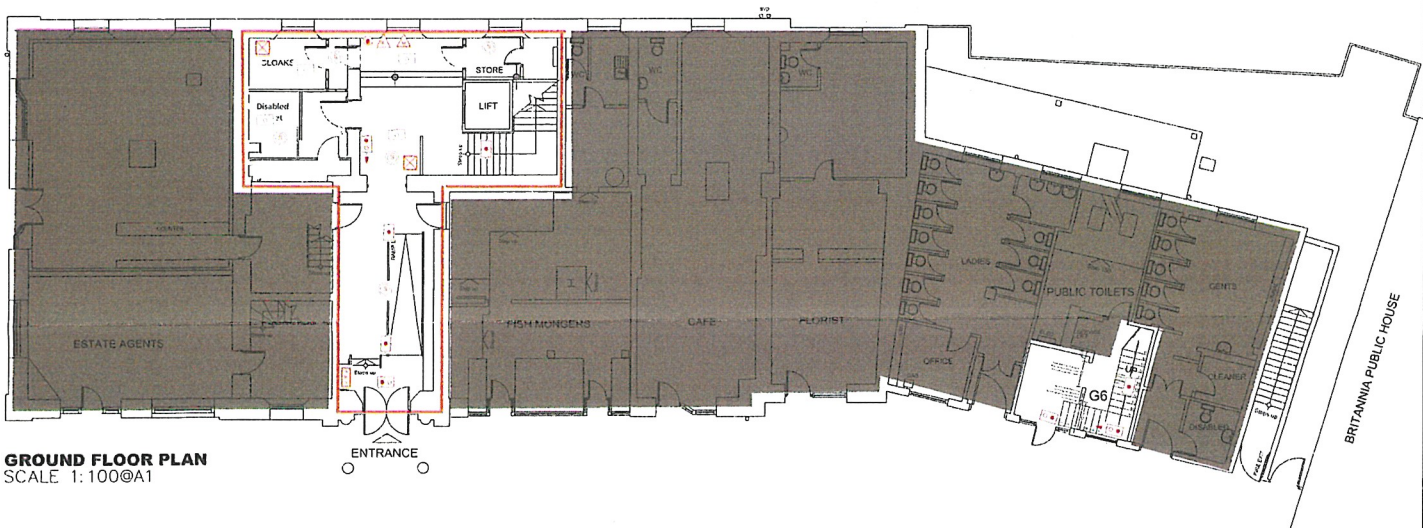

GROUND FLOOR PLAN
SCALE 1:100@A1

